

OWNER
MINNESOTA SPORTS FACILITIES AUTHORITY
900 SOUTH 5th STREET, MINNEAPOLIS, MN 55415

OWNER
MINNESOTA VIKINGS FOOTBALL, LLC
9500 VIKING DR., EDEN PRAIRIE, MN 55344

ARCHITECT / INTERIORS / BRANDING
HKS, INC.
3001 ST. PAUL ST., SUITE 100, DALLAS, TX 75201

ASSOCIATE ARCHITECT - SKIN
STUDIO FIVE ARCHITECTS
322 FIRST AVE. N, SUITE 600, MINNEAPOLIS, MN 55401

ASSOCIATE ARCHITECT - INTERIORS
STUDIO HIVE
901 NORTH 3rd ST., SUITE 228, MINNEAPOLIS, MN 55401

MEP / TECHNOLOGY / LIGHTING
H&E ENGINEERS, INC.
10555 WEST 43rd AVE., WHEAT RIDGE, CO 80033

STRUCTURAL ENGINEER
THORNTON TOMASETTI
12750 MERIT DR., SUITE 750, LB-7, DALLAS, TX 75255

CIVIL ENGINEER
EVS, INC.
10025 VALLEY VIEW, SUITE 140, EDEN PRAIRIE, MN 55344

LANDSCAPE ARCHITECT
OSLUND AND ASSOCIATES
115 WASHINGTON AVE. N, MINNEAPOLIS, MN 55401

AUDIO VISUAL CONSULTANTS
ACOUSTIC DIMENSIONS
15508 WRIGHT BROTHERS DR., ADDISON, TX 75001

WJHW
4601 SPRING VALLEY RD., DALLAS, TX 75244

CODE / FIRE PROTECTION
FSC, INC.
3225 NDIAN CREEK, SUITE 300, OVERLAND PK, KS 66210

FOOD SERVICE
RICCA NEWMARK
5325 SOUTH VALENTIA, GREENWOOD VLG, CO 80111

WAYFINDING
SECURITY MARKING DESIGN
432 CULVER BLVD., PLAYA DEL REY, CA 90235

VERTICAL TRANSPORTATION
ELEVATOR ADVISORY GROUP
1430 PRINCKA AVE., SAINT PAUL, MN 55124

ADA CONSULTANT
ED ROTHER CONSULTING, LLC
2990 MISSOURI BELLEVUE, COBURG, KS 65033

WIND / SNOW CONSULTANT
ROWAN, WILLIAMS, DAVIES, AND IRWIN, INC.
650 WOODLAWN RD. W., QUELPH, ON CANADA M1K 1B8

BUILDING ENVELOPE CONSULTANT
THORNTON TOMASETTI - BUILDING SKIN PRACTICE
330 N. WABASH AVE., SUITE 1500, CHICAGO, IL 60611

FAÇADE ACCESS CONSULTANT
LECHY BATES, INC.
8888 LINCOLN ST., SUITE 105, LITTLETON, CO 80122

MINNESOTA
MULTI-PURPOSE STADIUM

CERTIFICATION
I hereby certify that the plan, specification, or report was prepared by me or under my direct supervision and that I am a duly Licensed Professional Engineer under the laws of the State of Minnesota.
Name: Daniel E. Boyer
Reg. No.: 45018
Date: 5/02/2014
Signature: *[Signature]*

KEY PLAN

REVISION

NO.	DESCRIPTION	DATE
1	CCD-083	6/20/14
2	CCD-121	8/22/14
3	ASL-172	1/20/15
4	ASL-191	3/20/15
5	CCD-252	10/30/15
6	CCD-248	8/7/16

HKS PROJECT NUMBER
16246.000


DATE
MAY 2, 2014

ISSUE
CCD-060


SHEET TITLE
UTILITY PLAN

NE

SHEET NO.
C4.01

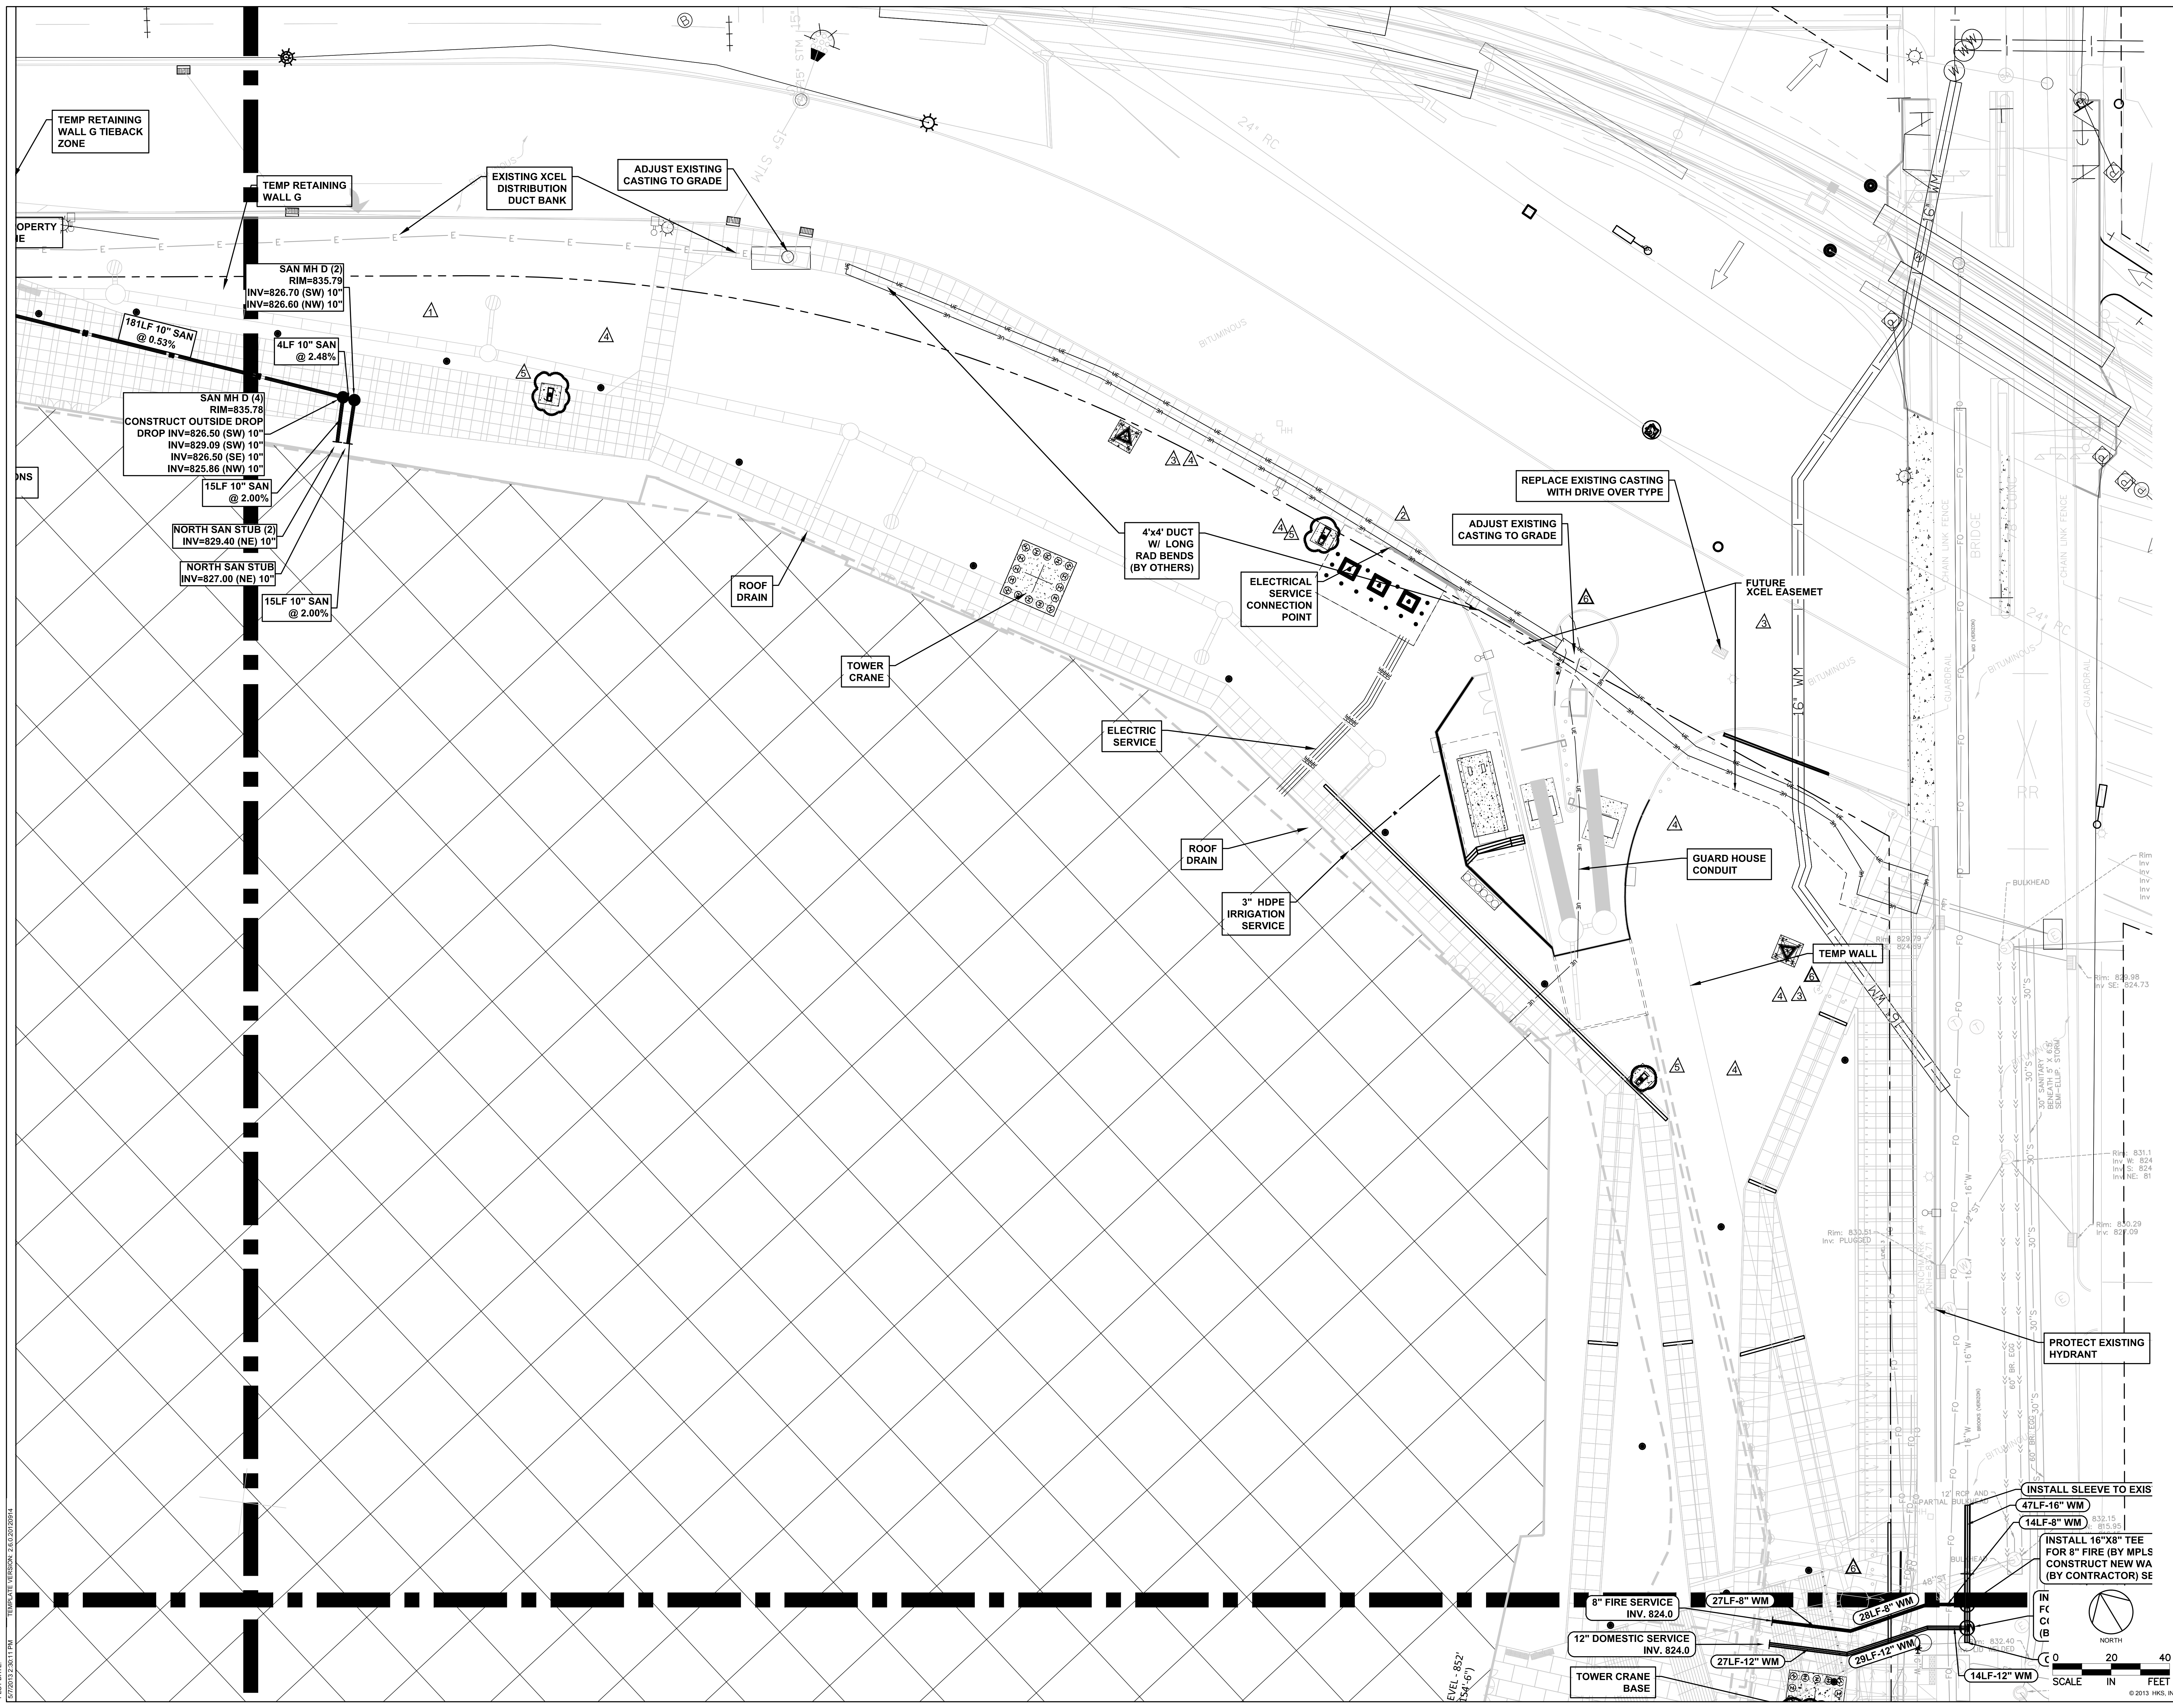

CERTIFICATION
I hereby certify that the plan, specification, or report was prepared by me or under my direct supervision and that I am a duly Licensed Professional Engineer under the laws of the State of Minnesota.
Name: Daniel E. Boyer
Reg. No.: 45018
Date: 5/02/2014
Signature: *[Signature]*

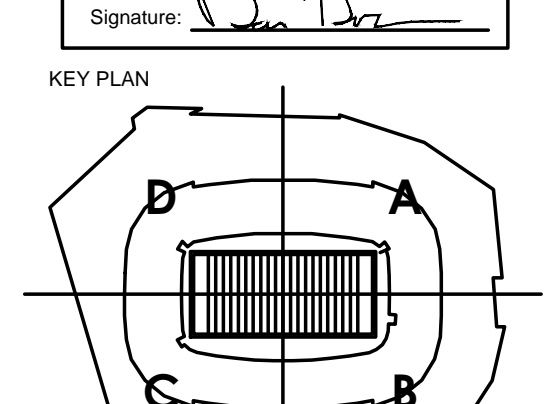

REVISION

NO.	DESCRIPTION	DATE
1	CCD-083	6/20/14
2	CCD-121	8/22/14
3	ASL-172	1/20/15
4	ASL-191	3/20/15
5	CCD-252	10/30/15
6	CCD-248	8/7/16

HKS PROJECT NUMBER
16246.000

DATE
MAY 2, 2014

ISSUE
CCD-060

SHEET TITLE
UTILITY PLAN

NE

SHEET NO.
C4.01